

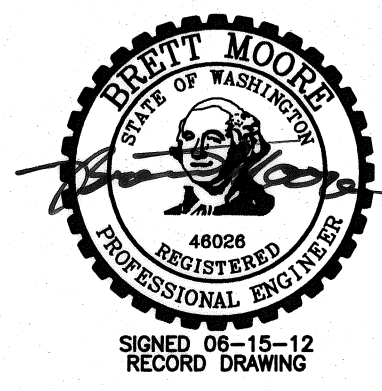


6" PRV/FCV STATION, SEE DETAIL, SHEET 119B. DOWNSTREAM PRESSURE SET AT 50 PSI. UPSTREAM OPERATIONAL PRESSURE APPROXIMATELY 95 PSI. STATIC PRESSURE APPROXIMATELY 127 PSI.

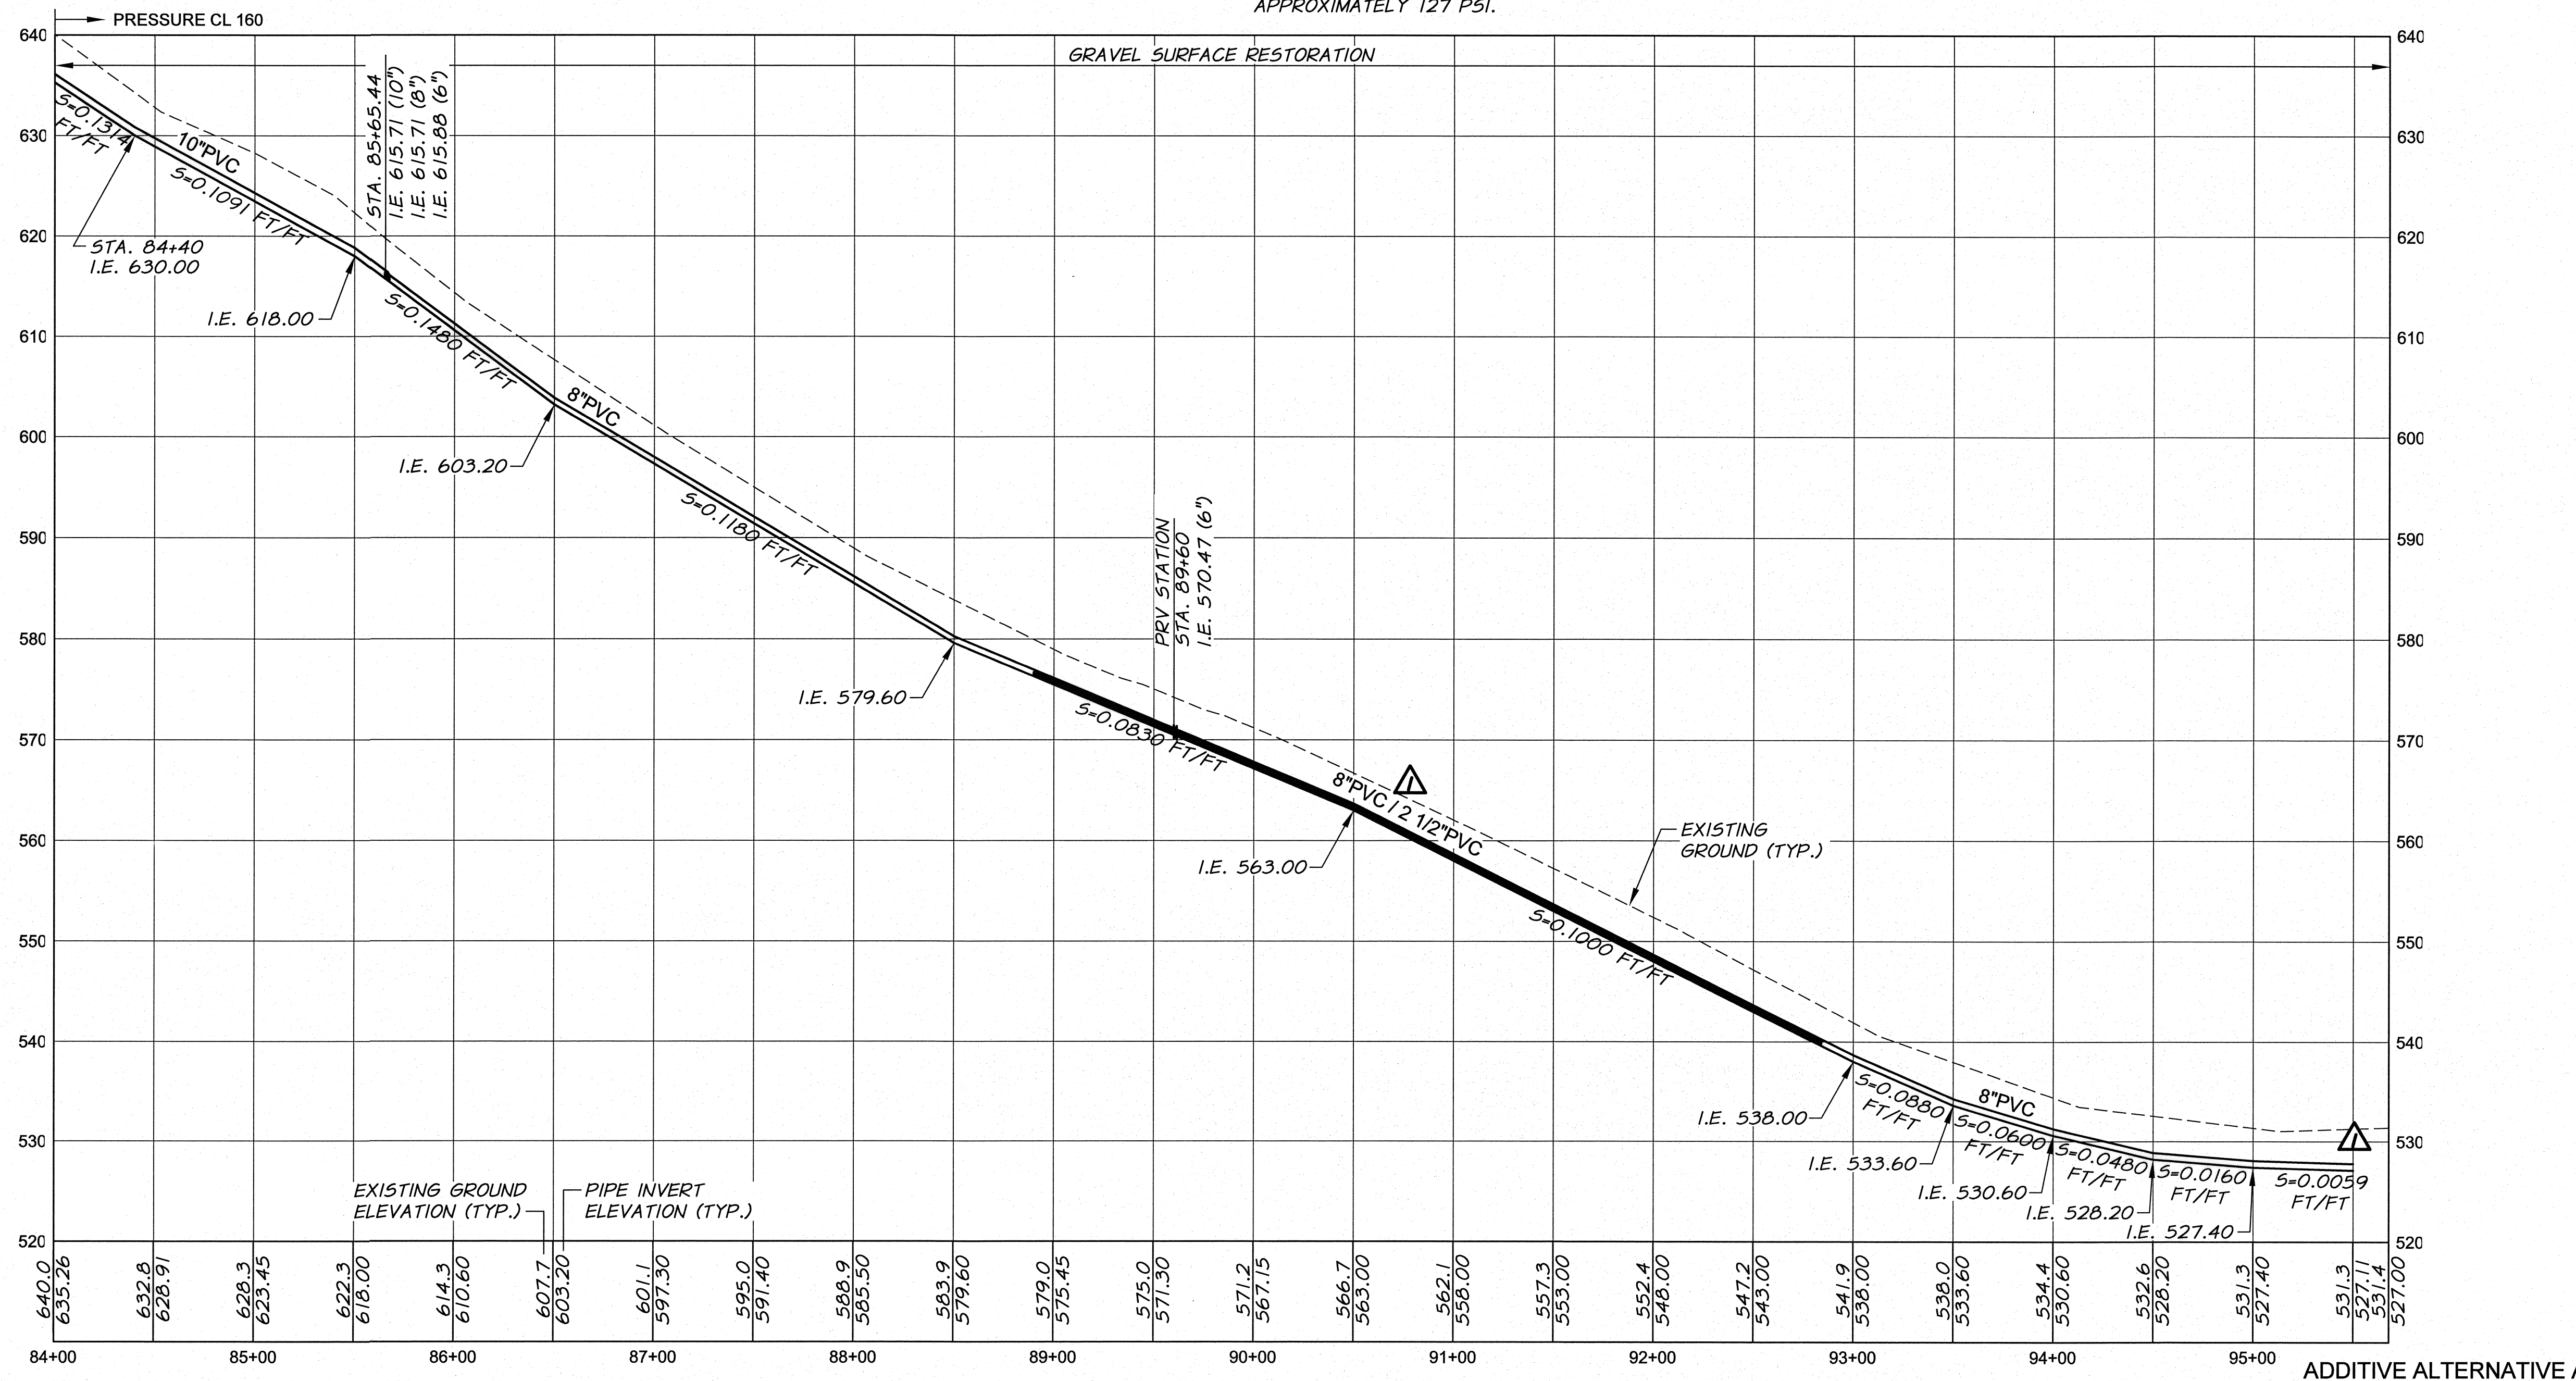

RECORD DRAWING		BY	E.H.	DATE	12/11
DESIGNED BY	R. HARRIS	XREFs:	TB-BID.dwg	JOB NUMBER	1199-336
DRAWN BY	R. RASMUSSEN	ACAD FILE:	EVERT-HORNE-PNP.dwg	DATE	2009
REVIEWED BY	H. PERRY	COPYRIGHT 2009 BY ANDERSON-PERRY & ASSOC., INC.			

RECORD DRAWINGS
 These record drawings have been prepared, in part, on the basis of information compiled and furnished by others. They may contain some discrepancies and omissions, and do not necessarily represent "exact" field conditions. The Owner and the Engineer accept no responsibility for their accuracy.

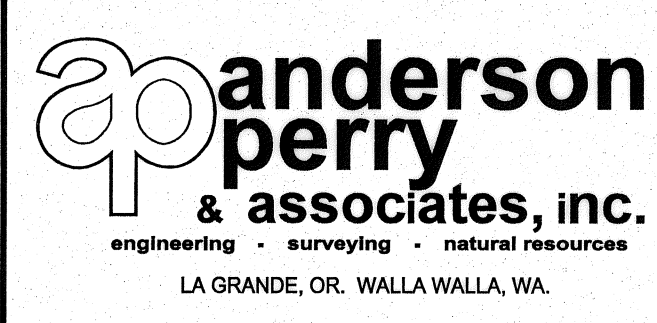

BENTON IRRIGATION DISTRICT
 IRRIGATION SYSTEM IMPROVEMENTS
 PHASE I
 EVERT ROAD TO HORNE ROAD PIPING
 PLAN AND PROFILE - STA. 84+00 TO 95+68

SHEET
101

ARCHIVED