


RECORD DRAWING		E.H.	12/11	SCALE IN FEET	
DESIGNED BY	R. HARRIS	DATE	12/11	HORIZ. SCALE	1"=50'
DRAWN BY	R. RASMUSSEN	DATE	2009	VERT. SCALE	1"=10'
REVIEWED BY	H. PERRY	JOB NUMBER 1199-336		ACAD FILE: NOREROZA.dwg	
XREFs: TB-BID.dwg		COPYRIGHT 2009 BY ANDERSON-PERRY & ASSOC., INC.			

### RECORD DRAWINGS

These record drawings have been prepared, in part, on the basis of information compiled and furnished by others. They may contain some discrepancies and omissions, and do not necessarily represent "exact" field conditions. The Owner and the Engineer accept no responsibility for their accuracy.

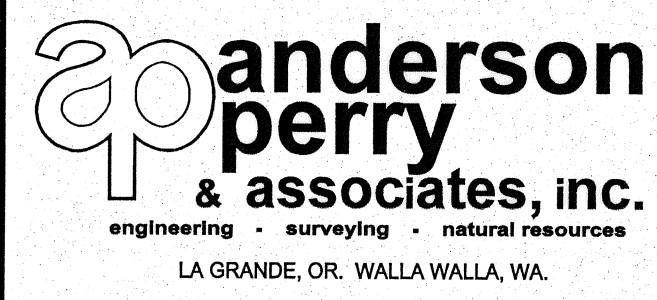

### BENTON IRRIGATION DISTRICT

#### IRRIGATION SYSTEM IMPROVEMENTS PHASE I

EAST ROZA NORTH PIPING  
PLAN AND PROFILE - STA. 1+00 TO 14+00

ADDITIVE ALTERNATIVE B

SHEET

11

ARCHIVED