



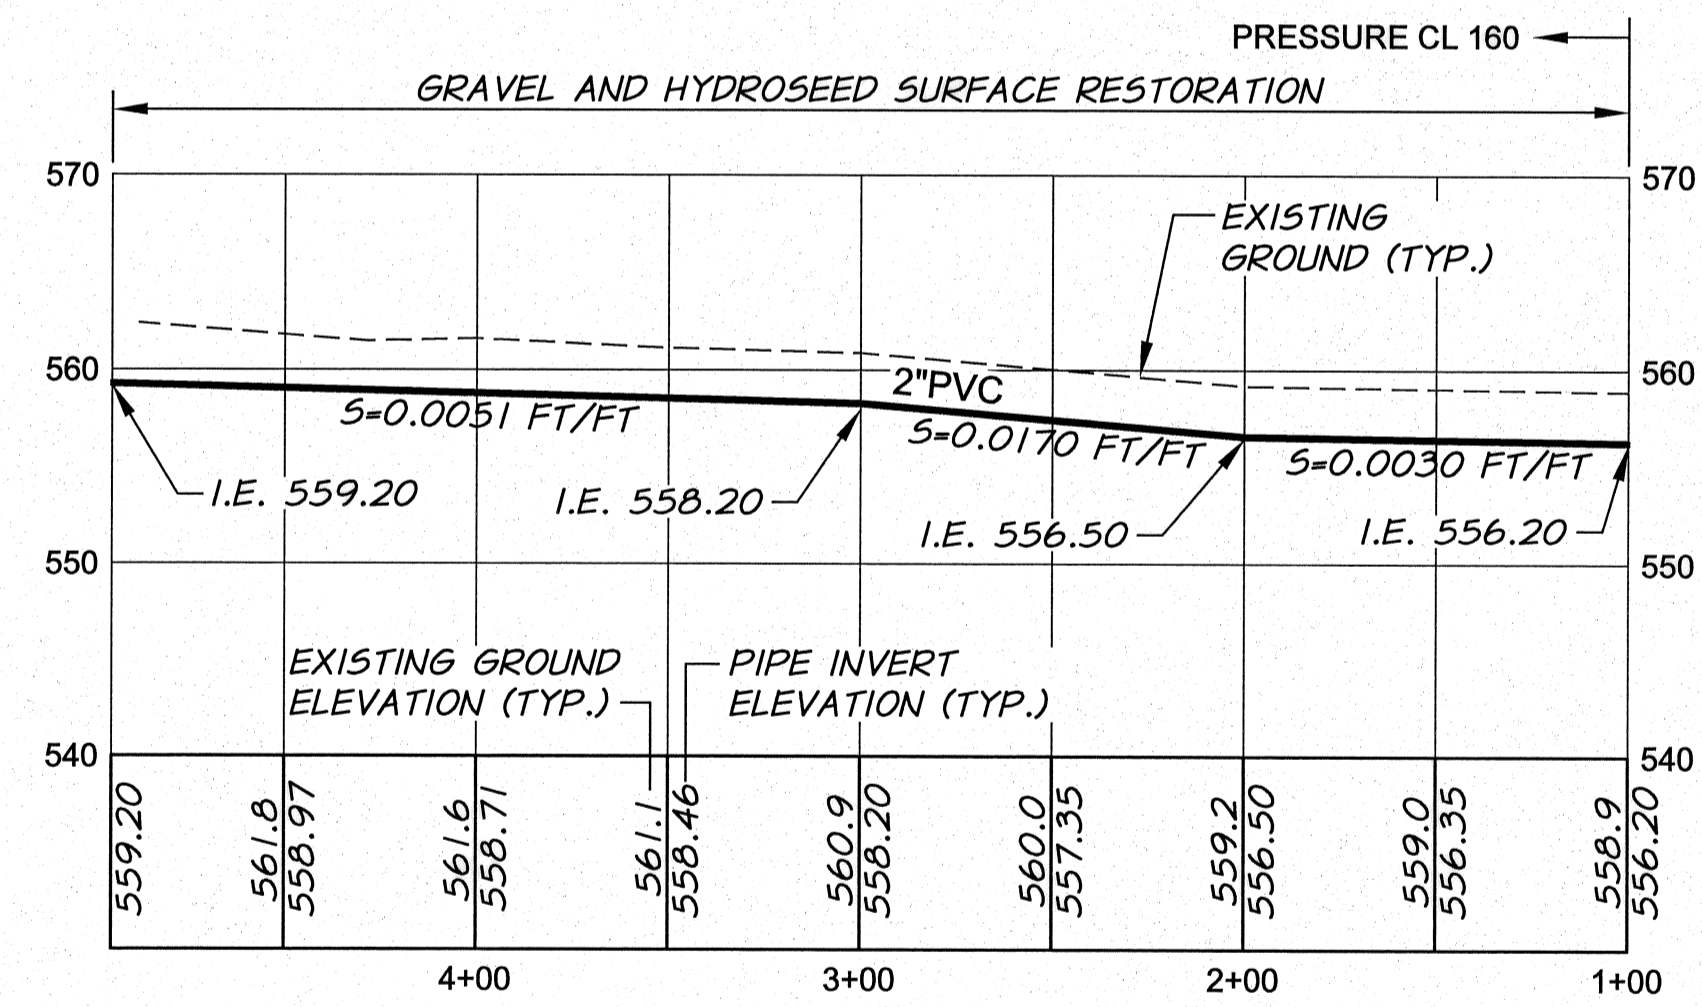


**CAUTION**  
FIBER OPTIC LINE IN AREA. COORDINATE WORK WITH VERIZON.

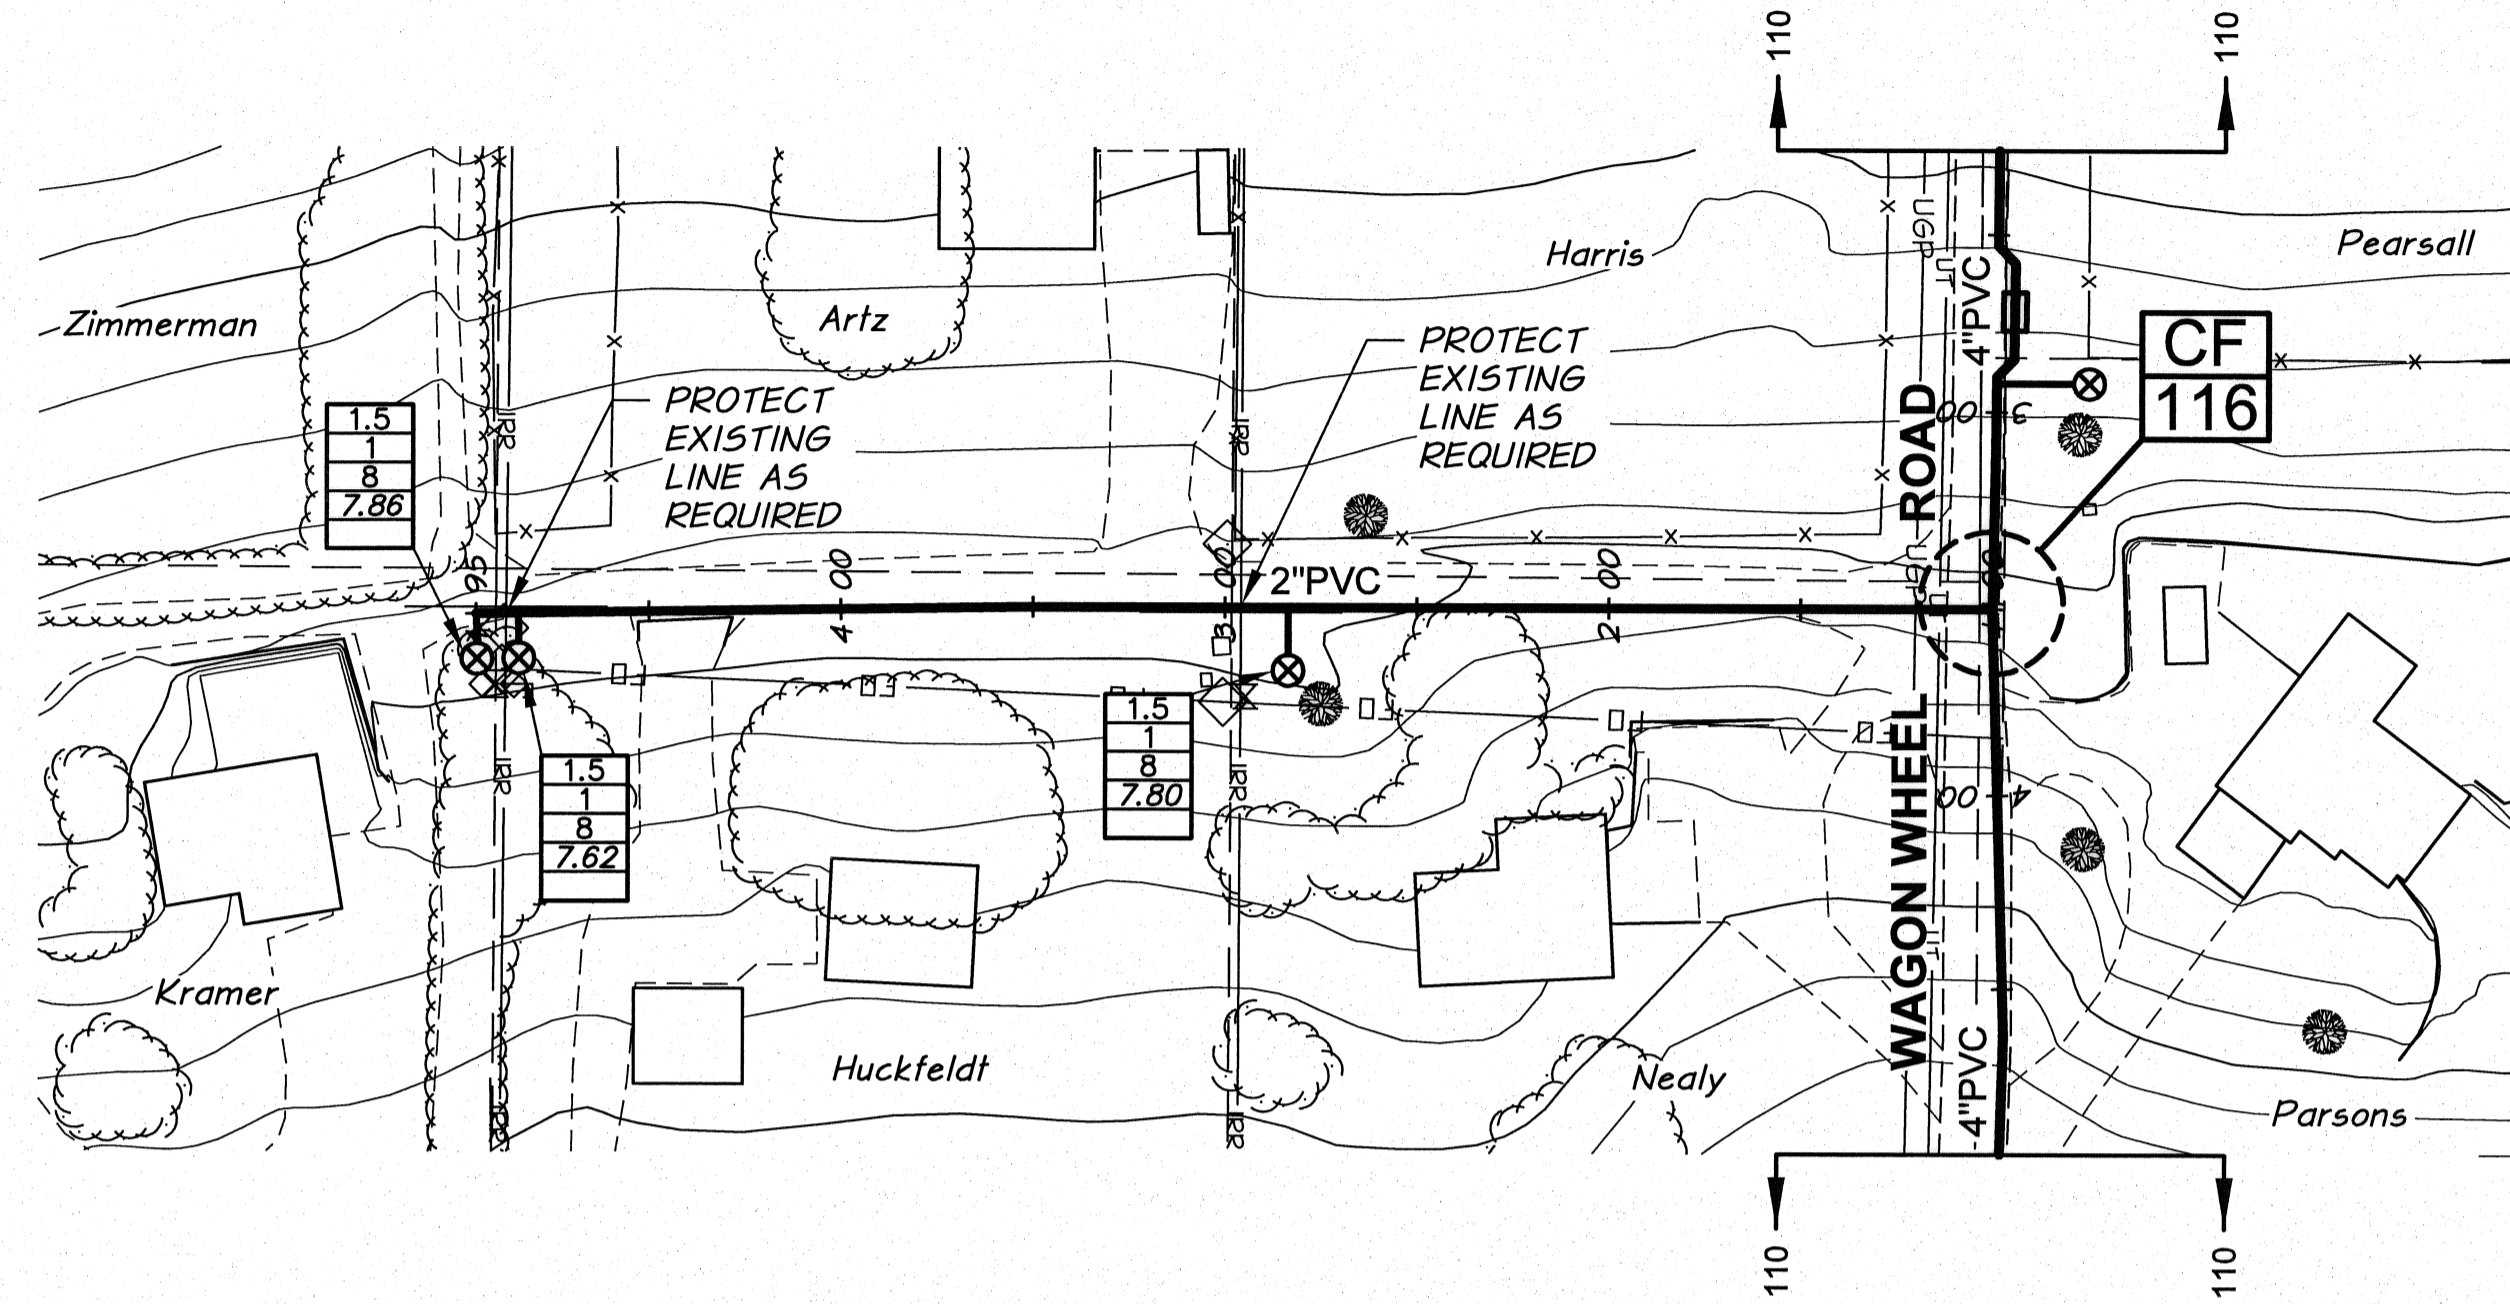

REVISION	BY	DATE	HORZ. SCALE 1"=50'	VERT. SCALE 1"=10'
DESIGNED BY R. HARRIS			JOB NUMBER 1199-336	DATE 2009
DRAWN BY R. RASMUSSEN			ACAD FILE: WAGONWHEEL-PNP.dwg	
REVIEWED BY H. PERRY			COPYRIGHT 2009 BY ANDERSON-PERRY & ASSOC., INC.	

**RECORD DRAWINGS**  
These record drawings have been prepared, in part, on the basis of information compiled and furnished by others. They may contain some discrepancies and omissions, and do not necessarily represent "exact" field conditions. The Owner and the Engineer accept no responsibility for their accuracy.

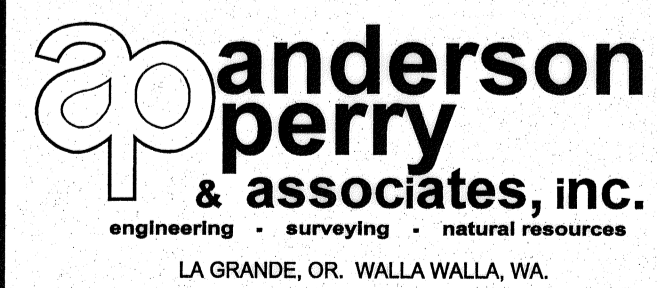

**BENTON IRRIGATION DISTRICT**  
IRRIGATION SYSTEM IMPROVEMENTS  
PHASE I  
**WAGON WHEEL ROAD PIPING**  
PLAN AND PROFILE - STA. 1+00 TO 4+95

SHEET  
**111**

ARCHIVED

Q:\BENTON I1199\_336\_PRESSURE\_PNP.dwg\WAGONWHEEL-PNP.dwg, WAGONWHEEL-SUB1, 6/22/2011, 11:28:44 AM