


REVISION	BY	DATE
RECORD DRAWING	E.H.	12/11
DESIGNED BY	XREFS: TB-BID.dwg	
DRAWN BY	R. RASMUSSEN	
REVIEWED BY	H. PERRY	

HORIZ. SCALE	1" = 50'	VERT. SCALE	1" = 10'
JOB NUMBER	1199-336	DATE	2009
ACAD FILE	NOREROZA.dwg		
COPYRIGHT 2009 BY ANDERSON-PERRY & ASSOC., INC.			

RECORD DRAWINGS

These record drawings have been prepared, in part, on the basis of information compiled and furnished by others. They may contain some discrepancies and omissions, and do not necessarily represent "exact" field conditions. The Owner and the Engineer accept no responsibility for their accuracy.

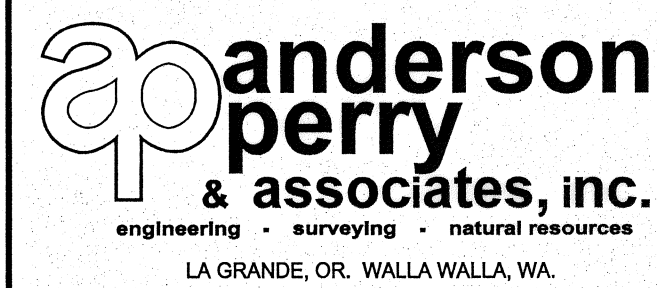

**BENTON IRRIGATION DISTRICT
IRRIGATION SYSTEM IMPROVEMENTS
PHASE I**

**EAST ROZA NORTH PIPING
PLAN AND PROFILE - STA. 1+00 TO 8+60**

ADDITIVE ALTERNATIVE B

SHEET
15

ARCHIVED