


RECORD DRAWING		E.H.	12/11
DESIGNED BY	R. HARRIS	XREFS:	TB-BID.dwg
DRAWN BY	R. RASMUSSEN	JOB NUMBER	1199-336
REVIEWED BY	H. PERRY	ACAD FILE	114TH-PNP.dwg
DATE: 2009			

SCALE IN FEET	
0 50 100 150	
SCALE IN FEET	
0 10 20 30	
HORIZ. SCALE	1"=50'
VERT. SCALE	1"=10'
COPYRIGHT 2009 BY ANDERSON-PERRY & ASSOC., INC.	

RECORD DRAWINGS
 These record drawings have been prepared, in part, on the basis of information compiled and furnished by others. They may contain some discrepancies and omissions, and do not necessarily represent "exact" field conditions. The Owner and the Engineer accept no responsibility for their accuracy.

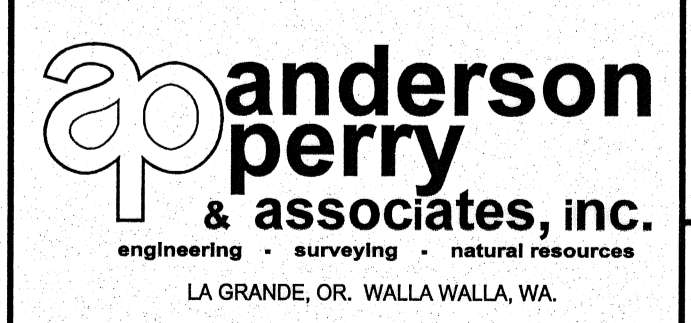

BENTON IRRIGATION DISTRICT
 IRRIGATION SYSTEM IMPROVEMENTS
 PHASE I
 114TH STREET PIPING
 PLAN AND PROFILE - STA. 1+00 TO 15+00

ADDITIVE ALTERNATIVE B
 SHEET
22