


ADDITIVE ALTERNATIVE B

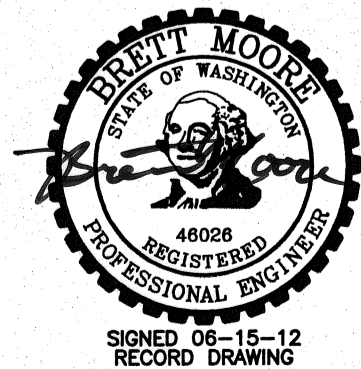


RECORD DRAWING		BY	E.H.	DATE	12/11
DESIGNED BY	R. HARRIS	XREFS:	TB-BID.dwg		
DRAWN BY	R. RASMUSSEN	JOB NUMBER	1199-336		
REVIEWED BY	H. PERRY	ACAD FILE	114TH-PNP.dwg		
		DATE	2009		

SCALE IN FEET		SCALE IN FEET	
1" = 50'		1" = 10'	
COPYRIGHT 2009 BY ANDERSON-PERRY & ASSOC., INC.			

RECORD DRAWINGS

These record drawings have been prepared, in part, on the basis of information compiled and furnished by others. They may contain some discrepancies and omissions, and do not necessarily represent "exact" field conditions. The Owner and the Engineer accept no responsibility for their accuracy.

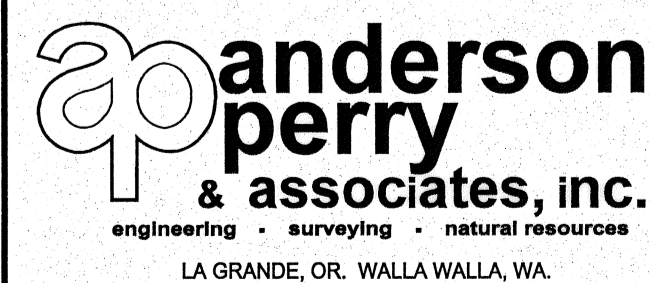

**BENTON IRRIGATION DISTRICT
IRRIGATION SYSTEM IMPROVEMENTS
PHASE I**

114TH STREET PIPING
PLAN AND PROFILE STA. 29+00 TO 35+61

SHEET

24

ARCHIVED