


| | | | | | | | |
|---|--------------|--------------|---------------|---------------|-------------|--------|------|
| RECORD DRAWING | | BY | E.H. | DATE | 12/11 | | |
| DESIGNED BY | R. HARRIS | XREFS: | TB-BID.dwg | | | | |
| DRAWN BY | D. CHRISTMAN | JOB NUMBER | 1199-336 | | | | |
| REVIEWED BY | H. PERRY | ACAD FILE: | 108TH-PNP.dwg | | | | |
| | | HORIZ. SCALE | | 1"=50' | VERT. SCALE | 1"=10' | |
| | | JOB NUMBER | | 1199-336 | DATE | | 2009 |
| | | ACAD FILE: | | 108TH-PNP.dwg | | | |
| COPYRIGHT 2009 BY ANDERSON-PERRY & ASSOC., INC. | | | | | | | |

RECORD DRAWINGS
 These record drawings have been prepared, in part, on the basis of information compiled and furnished by others. They may contain some discrepancies and omissions, and do not necessarily represent "exact" field conditions. The Owner and the Engineer accept no responsibility for their accuracy.

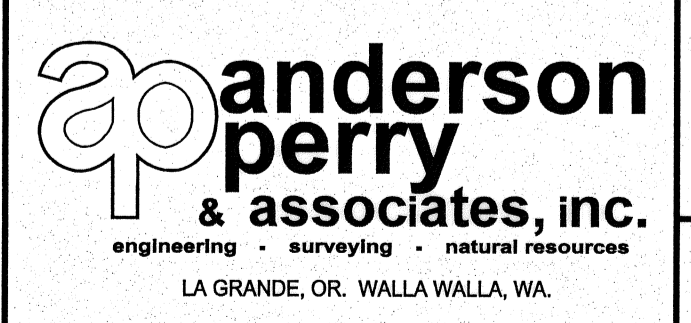

BENTON IRRIGATION DISTRICT
 IRRIGATION SYSTEM IMPROVEMENTS
 PHASE I
 108TH STREET PIPING
 PLAN AND PROFILE - STA. 1+00 TO 13+00

BASE BID
 SHEET
27