


RECORD DRAWING		BY	E.H.	DATE	12/11	
DESIGNED BY	R. HARRIS	XREFS:	TB-BID.dwg			
DRAWN BY	D. CHRISTMAN	JOB NUMBER	1199-336			
REVIEWED BY	H. PERRY	ACAD FILE:	108TH-PNP.dwg			
		HORIZ. SCALE	1"=50'		VERT. SCALE	1"=10'
		DATE		2009		
COPYRIGHT 2009 BY ANDERSON-PERRY & ASSOC., INC.						

RECORD DRAWINGS

These record drawings have been prepared, in part, on the basis of information compiled and furnished by others. They may contain some discrepancies and omissions, and do not necessarily represent "exact" field conditions. The Owner and the Engineer accept no responsibility for their accuracy.

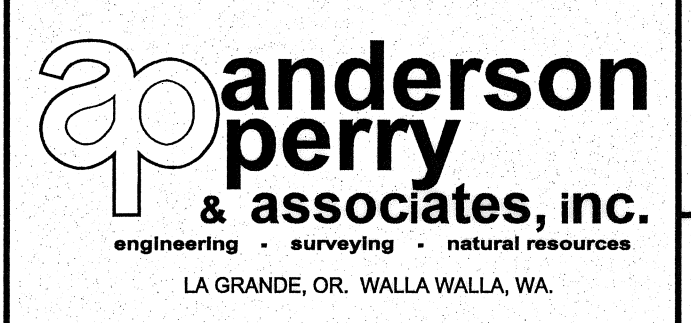

BENTON IRRIGATION DISTRICT

IRRIGATION SYSTEM IMPROVEMENTS

PHASE I

108TH STREET PIPING

PLAN AND PROFILE - STA. 13+00 TO 18+24

BASE BID

SHEET

28

ARCHIVED