


<b>RECORD DRAWING</b>		BY: E.H.	DATE: 12/11
DESIGNED BY: R. HARRIS	XREFS: TB-BID.dwg		
DRAWN BY: D. CHRISTMAN	JOB NUMBER: 1199-336	DATE: 2009	
REVIEWED BY: H. PERRY	ACAD FILE: WILLIAMS_WEST-PNP.dwg		

50' SCALE IN FEET	
SCALE IN FEET	
HORIZ. SCALE 1"=50'	VERT. SCALE 1"=10'
COPYRIGHT 2009 BY ANDERSON-PERRY & ASSOC., INC.	

**RECORD DRAWINGS**  
 These record drawings have been prepared, in part, on the basis of information compiled and furnished by others. They may contain some discrepancies and omissions, and do not necessarily represent "exact" field conditions. The Owner and the Engineer accept no responsibility for their accuracy.

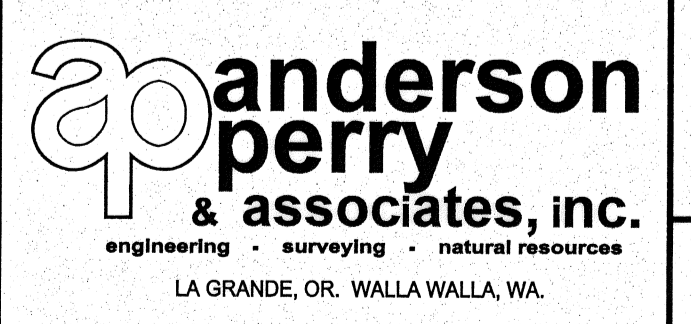

**BENTON IRRIGATION DISTRICT**  
 IRRIGATION SYSTEM IMPROVEMENTS  
 PHASE I  
 WILLIAMS ROAD PIPING  
 PLAN AND PROFILE - STA. 34+00 TO 48+00

ADDITIVE ALTERNATIVE A  
 SHEET  
**33**