


DESIGNED BY	R. HARRIS	DATE	
DRAWN BY	D. CHRISTMAN	JOB NUMBER	1199-336
REVIEWED BY	H. PERRY	DATE	2009
XREFS: TB-BID.dwg		ACAD FILE	WILLIAMS_WEST-PNP.dwg

SCALE IN FEET	
SCALE IN FEET	
HORIZ. SCALE	1" = 50'
VERT. SCALE	1" = 10'
COPYRIGHT 2009 BY ANDERSON-PERRY & ASSOC., INC.	

RECORD DRAWINGS
 These record drawings have been prepared, in part, on the basis of information compiled and furnished by others. They may contain some discrepancies and omissions, and do not necessarily represent "exact" field conditions. The Owner and the Engineer accept no responsibility for their accuracy.

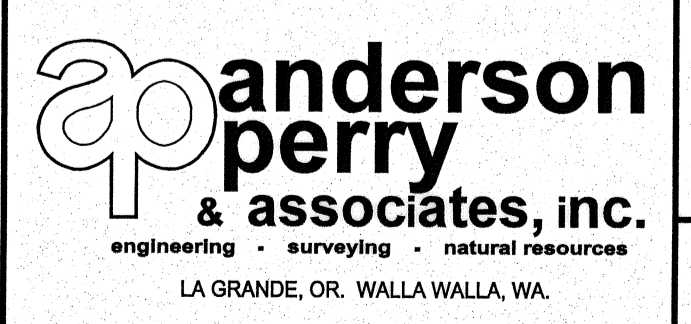

BENTON IRRIGATION DISTRICT
 IRRIGATION SYSTEM IMPROVEMENTS
 PHASE I
 WILLIAMS ROAD PIPING
 PLAN AND PROFILE - STA. 48+00 TO 60+00

ADDITIVE ALTERNATIVE A
 SHEET
34

ARCHIVED