


DESIGNED BY	R. HARRIS	XREFS:	TB-BID.dwg
DRAWN BY	D. CHRISTMAN		
REVIEWED BY	H. PERRY		

HORIZ. SCALE	1" = 50'	VERT. SCALE	1" = 10'
JOB NUMBER	1199-336	DATE	2009
ACAD FILE	HIGHLAND-PNP.dwg		
COPYRIGHT 2009 BY ANDERSON-PERRY & ASSOC., INC.			

**RECORD DRAWINGS**  
 These record drawings have been prepared, in part, on the basis of information compiled and furnished by others. They may contain some discrepancies and omissions, and do not necessarily represent "exact" field conditions. The Owner and the Engineer accept no responsibility for their accuracy.

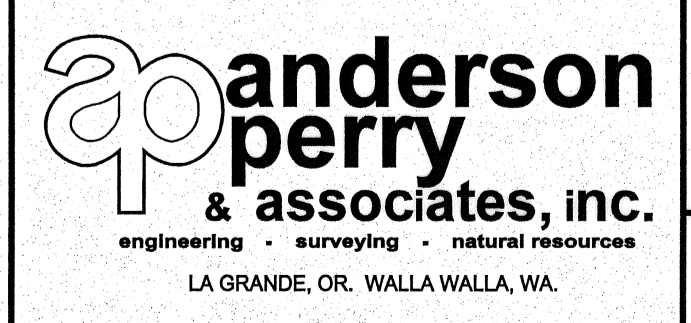

<b>BENTON IRRIGATION DISTRICT</b> IRRIGATION SYSTEM IMPROVEMENTS PHASE I HIGHLAND EXTENSION ROAD PIPING PLAN AND PROFILE - STA. 1+00 TO 14+00	SHEET <b>44</b>
---	--------------------

