

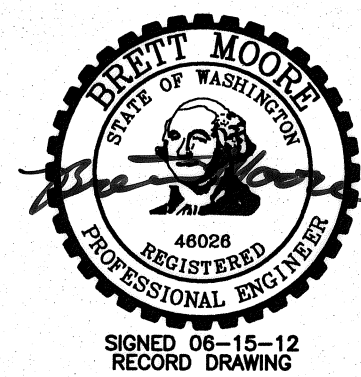
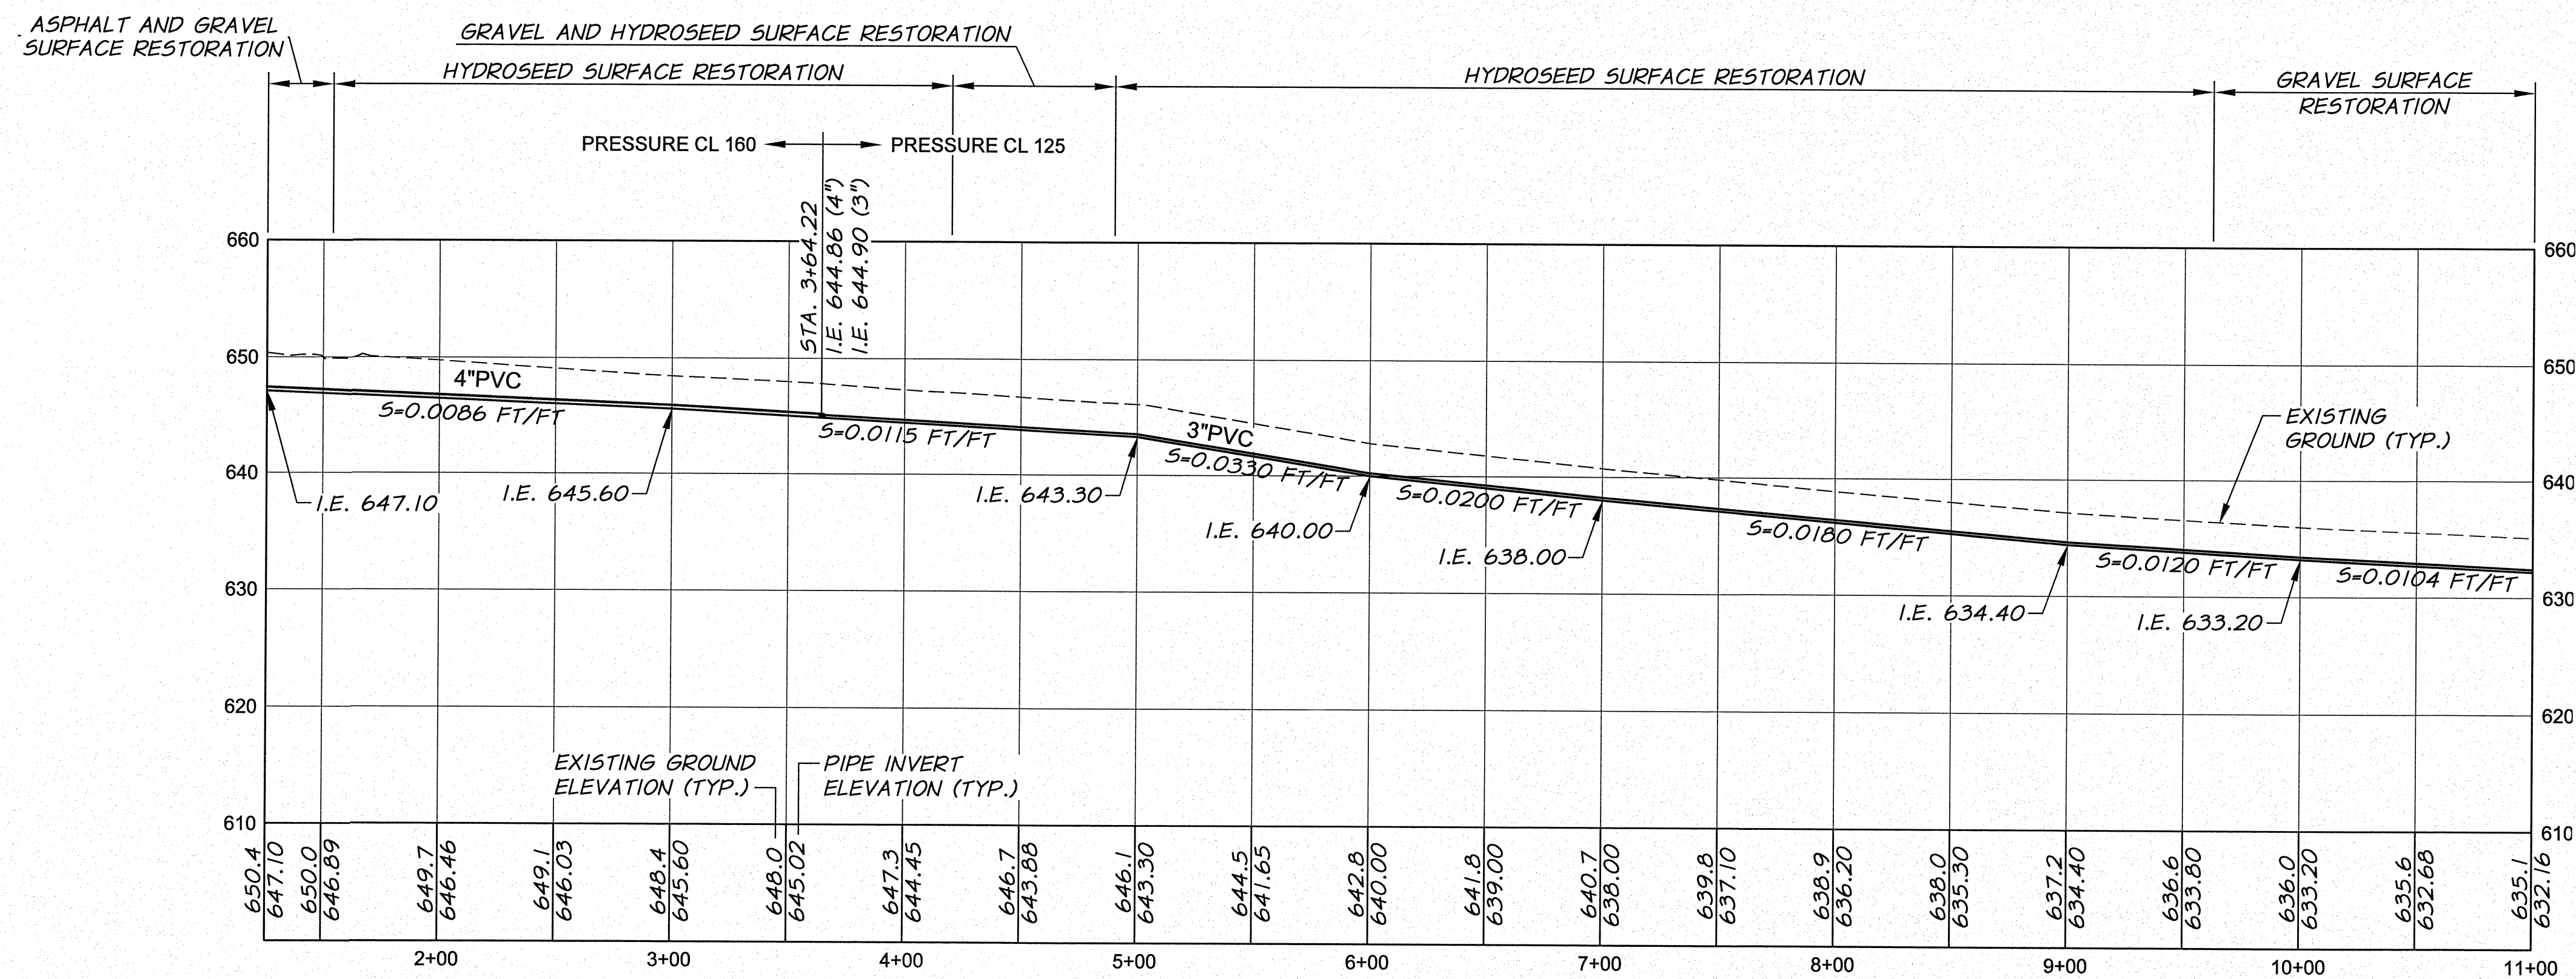


CAUTION
FIBER OPTIC LINE IN AREA. COORDINATE WORK WITH VERIZON.

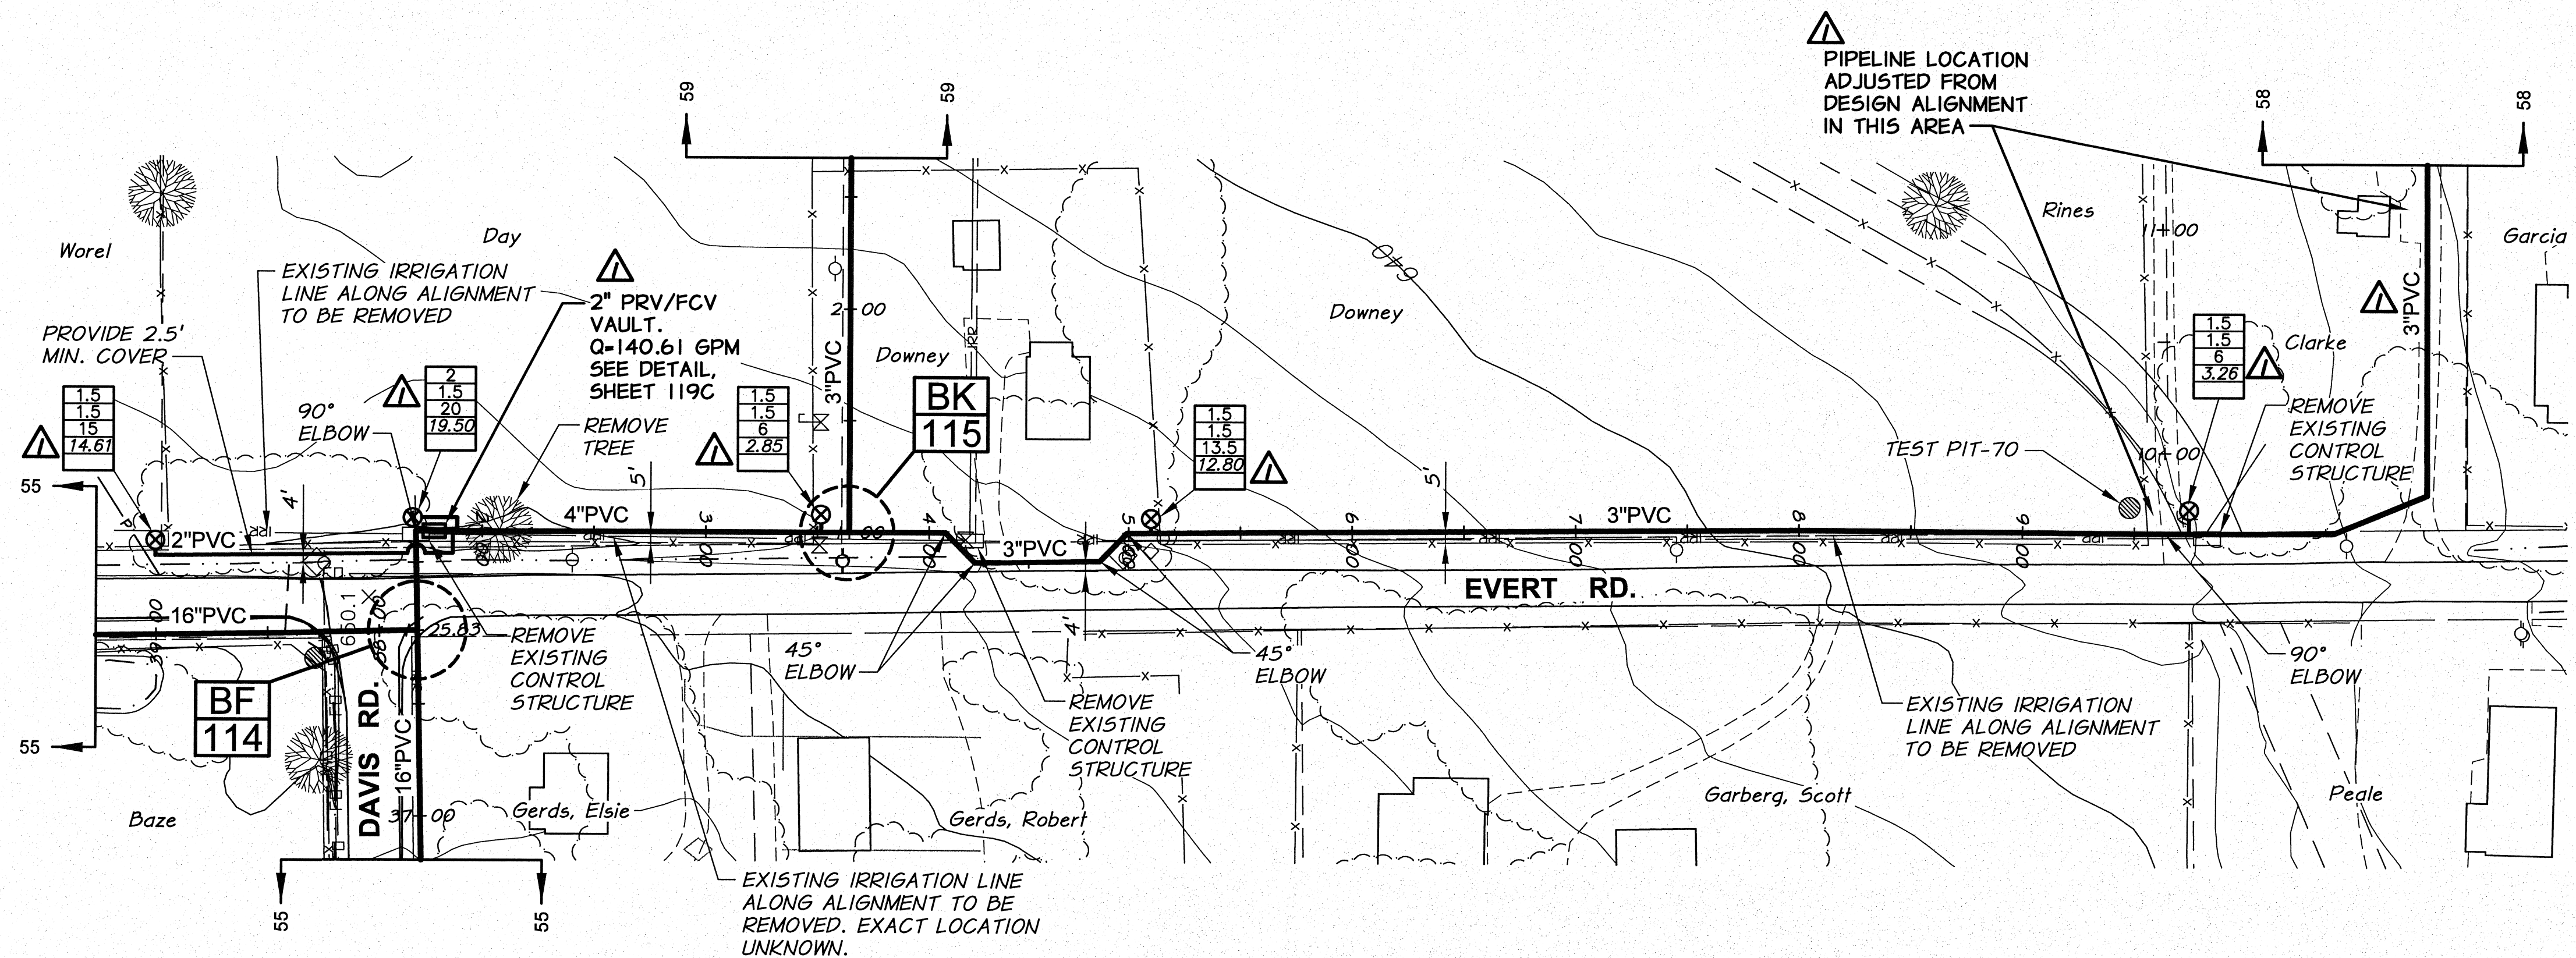


RECORD DRAWING		E.H.	12/11
DESIGNED BY	R. HARRIS	DATE	2009
DRAWN BY	R. RASMUSSEN	JOB NUMBER	1199-336
REVIEWED BY	H. PERRY	ACAD FILE	EVERT-PNP.dwg
XREFS: TB-DID.dwg		COPYRIGHT 2009 BY ANDERSON-PERRY & ASSOC., INC.	

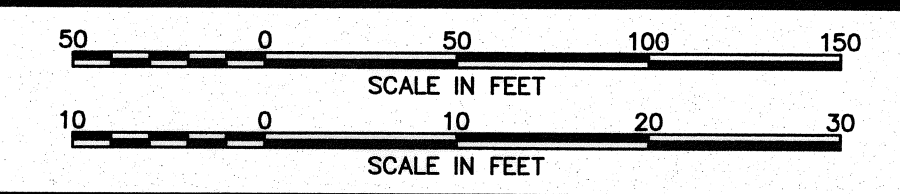

RECORD DRAWINGS

These record drawings have been prepared, in part, on the basis of information compiled and furnished by others. They may contain some discrepancies and omissions, and do not necessarily represent "exact" field conditions. The Owner and the Engineer accept no responsibility for their accuracy.

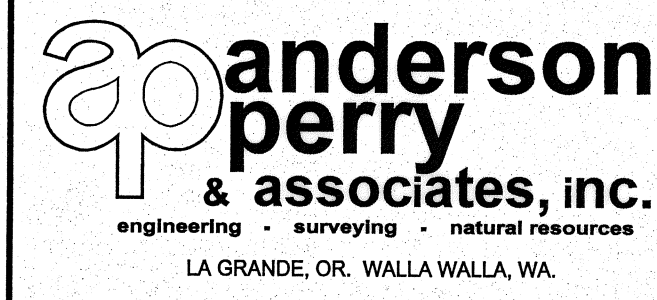

BENTON IRRIGATION DISTRICT
IRRIGATION SYSTEM IMPROVEMENTS
PHASE I

WHAN ROAD TO EVERT ROAD PIPING
PLAN AND PROFILE - STA. 1+26 TO 11+00

ADDITIVE ALTERNATIVE B

SHEET
57