


REVISION		BY	DATE
RECORD DRAWING		E.H.	12/11
DESIGNED BY	R. HARRIS	XREFS:	TB-BID.dwg
DRAWN BY	D. CHRISTMAN	JOB NUMBER	1199-336
REVIEWED BY	H. PERRY	DATE	2009
		ACAD FILE:	WILLIAMS_SOUTH-PNP.dwg

SCALE IN FEET	
0	50 100 150
SCALE IN FEET	
0	10 20 30
HORIZ. SCALE	1"=50'
VERT. SCALE	1"=10'
COPYRIGHT 2009 BY ANDERSON-PERRY & ASSOC., INC.	

RECORD DRAWINGS

These record drawings have been prepared, in part, on the basis of information compiled and furnished by others. They may contain some discrepancies and omissions, and do not necessarily represent "exact" field conditions. The Owner and the Engineer accept no responsibility for their accuracy.

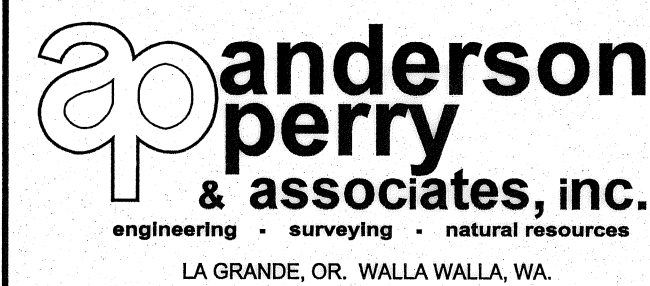

**BENTON IRRIGATION DISTRICT
IRRIGATION SYSTEM IMPROVEMENTS
PHASE I**

**WILLIAMS ROAD SOUTH PIPING
PLAN AND PROFILE - STA. 1+00 TO 5+45**

BASE BID

SHEET

74

ARCHIVED