


REVISION	BY	DATE	
RECORD DRAWING	E.H.	12/11	
DESIGNED BY	R. HARRIS		
DRAWN BY	D. CHRISTMAN		
REVIEWED BY	H. PERRY		
	XREFS: TB-BID.dwg		

HORZ. SCALE	1" = 50'	VERT. SCALE	1" = 10'
JOB NUMBER	1199-336		
DATE	2009		
ACAD FILE	WILLIAMS_SOUTH-PNP.dwg		
COPYRIGHT 2009 BY ANDERSON-PERRY & ASSOC., INC.			

RECORD DRAWINGS
 These record drawings have been prepared, in part, on the basis of information compiled and furnished by others. They may contain some discrepancies and omissions, and do not necessarily represent "exact" field conditions. The Owner and the Engineer accept no responsibility for their accuracy.

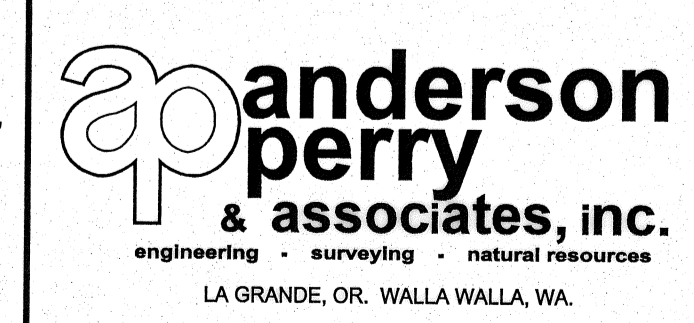

BENTON IRRIGATION DISTRICT
 IRRIGATION SYSTEM IMPROVEMENTS
 PHASE I
 WILLIAMS ROAD SOUTH PIPING
 PLAN AND PROFILE - STA. 1+00 TO 5+75

BASE BID
 SHEET
75