


REVISION	BY	DATE
RECORD DRAWING	E.H.	12/11
DESIGNED BY	R. HARRIS	
DRAWN BY	R. RASMUSSEN	
REVIEWED BY	H. PERRY	
XREFS: TB-BID.dwg		

SCALE IN FEET	0 50 100 150
SCALE IN FEET	0 10 20 30
HORIZ. SCALE	1" = 50'
VERT. SCALE	1" = 10'
JOB NUMBER	1199-336
DATE	2009
ACAD FILE:	HIGHLAND-FRAZIER-PNP.dwg
COPYRIGHT 2009 BY ANDERSON-PERRY & ASSOC., INC.	

RECORD DRAWINGS

These record drawings have been prepared, in part, on the basis of information compiled and furnished by others. They may contain some discrepancies and omissions, and do not necessarily represent "exact" field conditions. The Owner and the Engineer accept no responsibility for their accuracy.

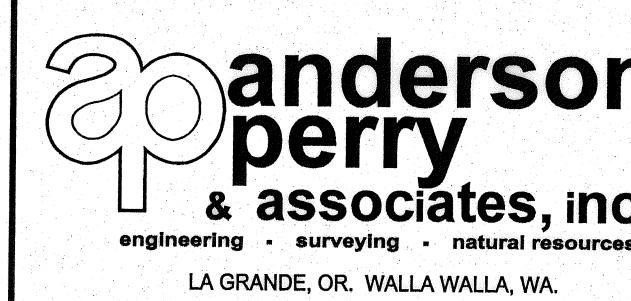

BENTON IRRIGATION DISTRICT

IRRIGATION SYSTEM IMPROVEMENTS

PHASE I

HIGHLAND ROAD TO FRAZIER ROAD PIPING
PLAN AND PROFILE - STA. 1+00 TO 13+00

ADDITIVE ALTERNATIVE B

SHEET

93

ARCHIVED