


RECORD DRAWING		E.H.	12/11
DESIGNED BY	R. HARRIS	BY	XREFs: TB-BID.dwg
DRAWN BY	R. RASMUSSEN	DATE	2009
REVIEWED BY	H. PERRY	ACAD FILE:	EVERT-HORNE-PNP.dwg

SCALE IN FEET	
0 50 100 150	0 20 30
SCALE IN FEET	
HORIZ. SCALE 1"=50'	VERT. SCALE 1"=10'
JOB NUMBER 1199-336	
ACAD FILE: EVERT-HORNE-PNP.dwg	
DATE 2009	
COPYRIGHT 2009 BY ANDERSON-PERRY & ASSOC., INC.	

**RECORD DRAWINGS**  
 These record drawings have been prepared, in part, on the basis of information compiled and furnished by others. They may contain some discrepancies and omissions, and do not necessarily represent "exact" field conditions. The Owner and the Engineer accept no responsibility for their accuracy.

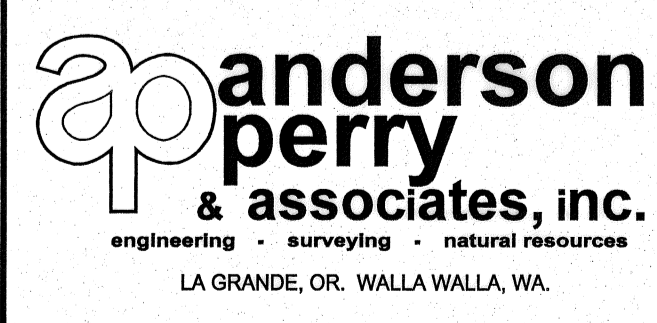

**BENTON IRRIGATION DISTRICT**  
 IRRIGATION SYSTEM IMPROVEMENTS  
 PHASE I  
 EVERT ROAD TO HORNE ROAD PIPING  
 PLAN AND PROFILE - STA. 1+00 TO 15+00

ADDITIVE ALTERNATIVE B  
 SHEET  
**95**