


SIGNED 06-04-12  
RECORD DRAWINGS

RECORD DRAWINGS		BY	B.M.	DATE	5/12
DESIGNED BY	R. HARRIS	XREFS: TB-BID.dwg			
DRAWN BY	D. CHRISTMAN				
REVIEWED BY	B. MOORE				

 HORZ. SCALE IN FEET 1"=50'		 VERT. SCALE IN FEET 1"=10'	
JOB NUMBER	1199-336	DATE	2011
ACAD FILE:	West_Main_A.dwg		
COPYRIGHT 2011 BY ANDERSON-PERRY & ASSOC., INC.			

**RECORD DRAWINGS**  
 These record drawings have been prepared, in part, on the basis of information compiled and furnished by others. They may contain some discrepancies and omissions, and do not necessarily represent "exact" field conditions. The Owner and the Engineer accept no responsibility for their accuracy.

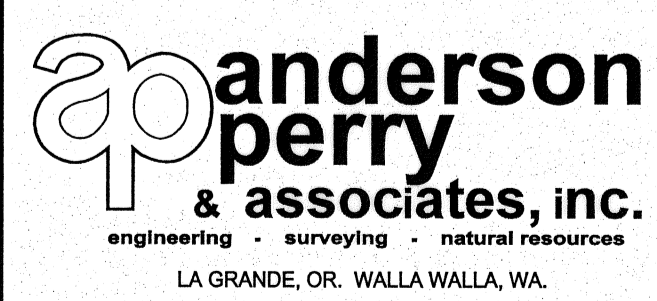

**BENTON IRRIGATION DISTRICT**  
 IRRIGATION SYSTEM IMPROVEMENTS  
 PHASE 2B  
 CORRAL CREEK TO POWER PLANT PIPING  
 STA. 43+00 TO STA. 57+00

SHEET  
**6**