


RECORD DRAWINGS		BY	B.M.	DATE	5/12
DESIGNED BY	R. HARRIS	XREFS:	TB-BID.dwg		
DRAWN BY	D. CHRISTMAN	JOB NUMBER	1199-336		
REVIEWED BY	B. MOORE	ACAD FILE	West_Main_A.dwg		
		HORIZ. SCALE	1"=50'	VERT. SCALE	1"=10'
		DATE	2011		
COPYRIGHT 2011 BY ANDERSON-PERRY & ASSOC., INC.					

**RECORD DRAWINGS**  
These record drawings have been prepared, in part, on the basis of information compiled and furnished by others. They may contain some discrepancies and omissions, and do not necessarily represent "exact" field conditions. The Owner and the Engineer accept no responsibility for their accuracy.

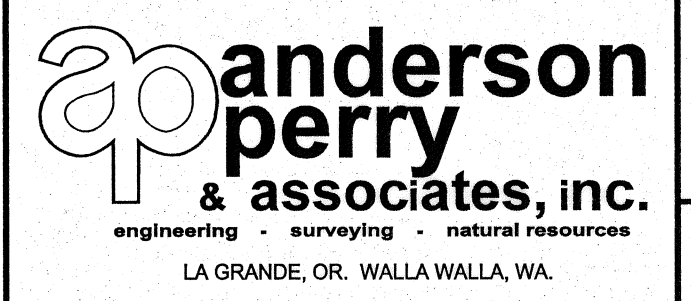

**BENTON IRRIGATION DISTRICT**  
IRRIGATION SYSTEM IMPROVEMENTS  
PHASE 2B  
CORRAL CREEK TO POWER PLANT PIPING  
STA. 71+00 TO STA. 85+00