
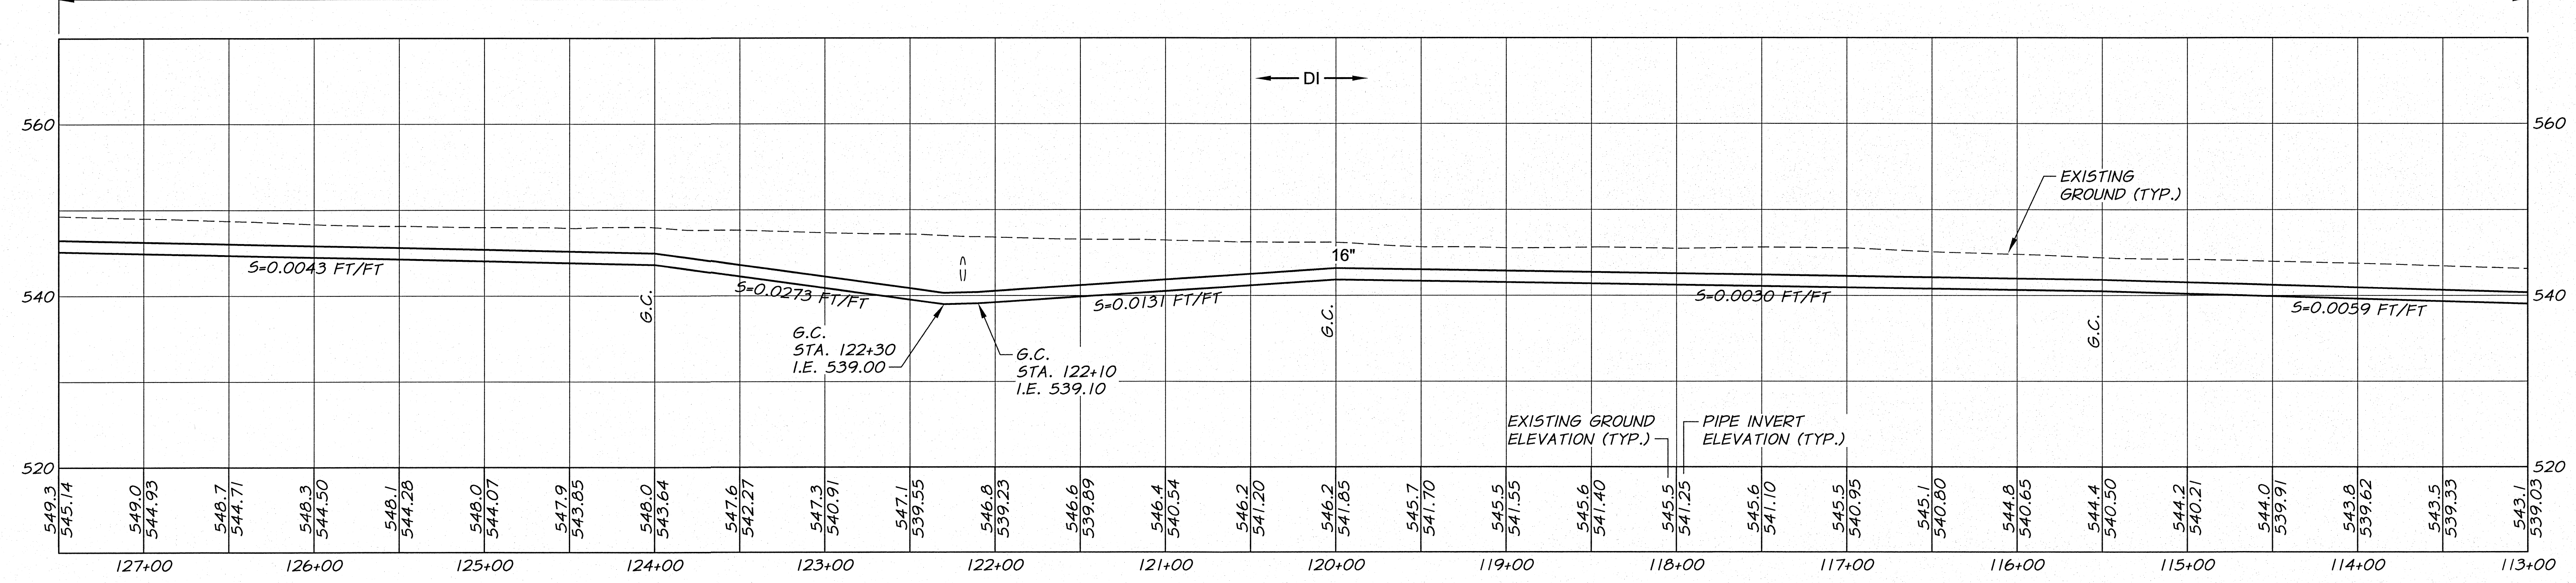



RAILROAD GRADE GRAVEL SURFACE RESTORATION

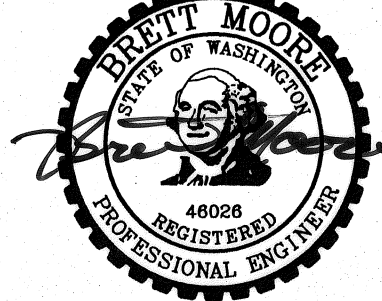


 SIGNED 06-04-12
 RECORD DRAWINGS

RECORD DRAWINGS REVISION: _____ DRAWN BY: R. HARRIS DRAWN BY: D. CHRISTMAN REVIEWED BY: B. MOORE		B.M. 5/12 BY: _____ DATE: _____ XREFS: TB-BID.dwg	50 0 50 100 150 10 0 20 30 HORIZ. SCALE IN FEET VERT. SCALE IN FEET HORIZ. SCALE 1"=50' VERT. SCALE 1"=10' JOB NUMBER 1199-336 DATE 2011 ACAD FILE: West_Main_A.dwg COPYRIGHT 2011 BY ANDERSON-PERRY & ASSOC., INC.
---	--	--	--

RECORD DRAWINGS
 These record drawings have been prepared, in part, on the basis of information compiled and furnished by others. They may contain some discrepancies and omissions, and do not necessarily represent "exact" field conditions. The Owner and the Engineer accept no responsibility for their accuracy.

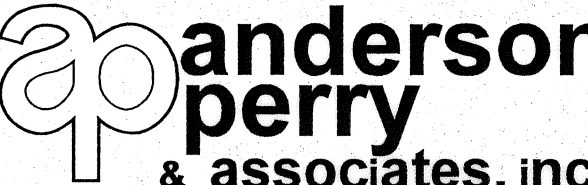
anderson perry & associates, inc.
 engineering • surveying • natural resources
 LA GRANDE, OR. WALLA WALLA, WA.

BENTON IRRIGATION DISTRICT
 IRRIGATION SYSTEM IMPROVEMENTS
 PHASE 2B
 CORRAL CREEK TO POWER PLANT PIPING
 STA. 113+00 TO STA. 127+50

SHEET
11