


- NOTES:**
1. MAINTAIN MINIMUM 2.5 FOOT COVER OVER PIPE.
 2. HYDROSEED AND RAILROAD GRADE SURFACE RESTORATION. SEE TECHNICAL SPECIFICATIONS.
 3. MAINTAIN POSITIVE GRADE FROM MAIN LINE TO END OF SERVICE LINE.

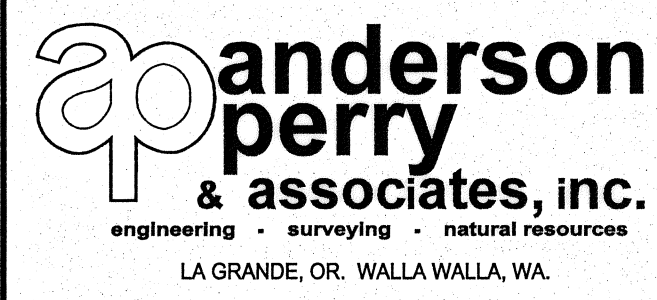

RECORD DRAWINGS		B.M.	5/12	 	
DESIGNED BY	R. HARRIS	BY	DATE	HORIZ. SCALE	1" = 50'
DRAWN BY	D. CHRISTMAN			VERT. SCALE	1" = 10'
REVIEWED BY	B. MOORE			JOB NUMBER	1199-336
				DATE	2011
				ACAD FILE:	West_Main_A.dwg
				COPYRIGHT 2011 BY ANDERSON-PERRY & ASSOC., INC.	

RECORD DRAWINGS
 These record drawings have been prepared, in part, on the basis of information compiled and furnished by others. They may contain some discrepancies and omissions, and do not necessarily represent "exact" field conditions. The Owner and the Engineer accept no responsibility for their accuracy.



BENTON IRRIGATION DISTRICT
 IRRIGATION SYSTEM IMPROVEMENTS
 PHASE 2B
 CORRAL CREEK TO POWER PLANT PIPING
 STA. 1+00 TO STA. 4+20

SHEET
13