


BLOW-OFF ORIENTATION
(IDA AVE/13th ST.)
N.T.S.

| SURFACE RESTORATION SCHEDULE | | |
|------------------------------|-----------------|----------------------|
| LINE | LOCATION (STA.) | DESCRIPTION |
| 4A | 1+00 TO 1+16 | LANDSCAPE AND GRAVEL |
| | 1+16 TO 1+73 | ASPHALT |
| | 1+73 TO 2+94 | GRAVEL |
| | 2+94 TO 3+19 | ASPHALT |
| | 3+19 TO 7+45 | GRAVEL AND GENERAL |
| | 7+45 TO 9+17 | GRAVEL |
| | 9+17 TO 9+67 | ASPHALT |
| 4B | 9+67 TO 9+81 | GRAVEL |
| | 1+00 TO 4+94 | HYDROSEED |
| 4C | 1+00 TO 1+10 | ASPHALT |
| | 1+10 TO 2+00 | GRAVEL |
| | 2+00 TO 7+20 | HYDROSEED |

| GRADE CONTROL SCHEDULE | | | |
|------------------------|-----------|---------|----------------------------|
| LINE | FROM STA. | TO STA. | CONTINUOUS SLOPE DIRECTION |
| 4A | 1+00 | 1+81 | DOWNWARD |
| | 1+81 | 2+39 | *UPWARD |
| | 2+39 | 5+60 | DOWNWARD |
| | 5+60 | 7+50 | UPWARD |
| 4B | 7+50 | 9+81 | **DOWNWARD |
| | 1+00 | 4+05 | DOWNWARD |
| 4C | 4+05 | 4+94 | UPWARD |
| | 1+00 | 7+20 | DOWNWARD |


*NOTE: 2 1/2" PARALLEL LINE TO SLOPE CONTINUOUSLY DOWNWARD FROM HORNE ROAD TO CONNECTION AT PRV/FCV STATION.
 **NOTE: 2 1/2" PARALLEL LINE TO SLOPE CONTINUOUSLY UPWARD FROM CONNECTION AT IRMA LANE TO PRV MANHOLE.

- NOTES:**
- MINIMUM COVER FROM FINISH GRADE TO TOP OF PIPE SHALL BE 2.5 FEET AND 3 FEET UNDER ROADWAYS, UNLESS NOTED OTHERWISE.
 - MINIMUM SLOPE OF INSTALLED PIPING SHALL BE 0.003 FT/FT.
 - LOT LINES AND RIGHT-OF-WAYS SHOWN ARE APPROXIMATE ONLY.
 - IT IS ANTICIPATED THE TELEPHONE, POWER, CABLE T.V., WATER, AND SEWER THAT EXIST WITHIN THE STREET AND UTILITY CORRIDOR AND INDIVIDUALLY PROVIDE SERVICE TO EACH LOT WILL BE ENCOUNTERED DURING CONSTRUCTION. CONTRACTOR SHALL PLAN FOR CROSSING AND/OR EXCAVATING ALONG THESE UTILITIES AT EACH LOT AND/OR WITHIN THE STREET AND UTILITY CORRIDOR WITHOUT ADDITIONAL COMPENSATION.
 - SERVICES LOCATED DOWNHILL OF MAIN LINE ARE TO DRAIN BACK TO MAIN LINE, UNLESS DESIGNATED "WITH DRAIN".

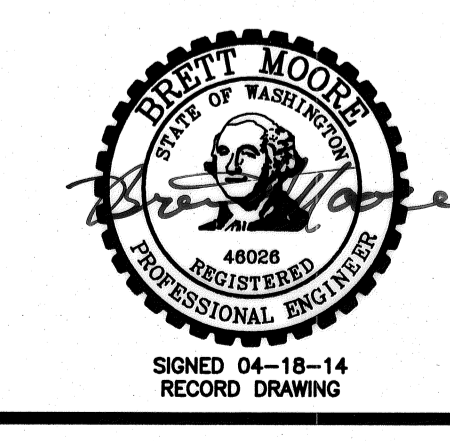

| | | | | | |
|----------------|--------------|-------------|-----------------|---|------|
| RECORD DRAWING | | B.M. | 4/14 | SCALE IN FEET | |
| DESIGNED BY | H. MORRISON | HORZ. SCALE | 1"=50' | VERT. SCALE | |
| DRAWN BY | D. CHRISTMAN | JOB NUMBER | 1199-336 | DATE | 2013 |
| REVIEWED BY | B. MOORE | ACAD FILE | PNP-Phase3C.dwg | COPYRIGHT 2013 BY ANDERSON-PERRY & ASSOC., INC. | |

RECORD DRAWINGS
APRIL 18, 2014
These record drawings have been prepared, in part, on the basis of information compiled and furnished by others. They may contain some discrepancies and omissions, and do not necessarily represent "exact" field conditions. The Owner and the Engineer accept no responsibility for their accuracy.

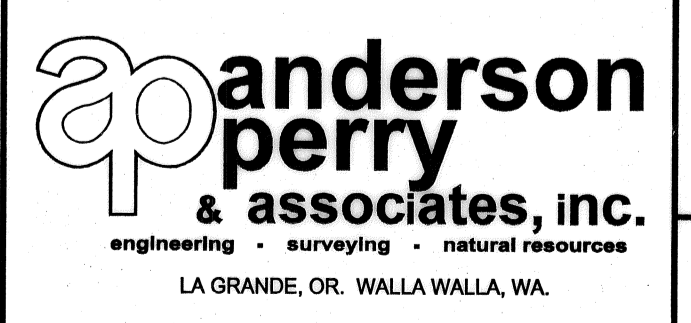

BENTON IRRIGATION DISTRICT
IRRIGATION SYSTEM IMPROVEMENTS
PHASE 3C
PIPING PLANS
IDA AVENUE AND IRMA LANE