

SURFACE RESTORATION SCHEDULE			
LINE	LOCATION (STA.)	DESCRIPTION	
7A	11TH STREET	1+00 TO 2+75	GRAVEL
		2+75 TO 4+05	GRAVEL AND HYDROSEED
		4+05 TO 9+03	GRAVEL
		9+03 TO 9+41	ASPHALT
		9+41 TO 10+90	GRAVEL
		10+90 TO 11+80	GRAVEL AND HYDROSEED
		11+80 TO 12+33	ASPHALT
		12+33 TO 13+11	LANDSCAPE
		13+11 TO 14+50	GRAVEL
7B	ALLEY	1+00 TO 1+21	ASPHALT
		1+21 TO 6+21	LANDSCAPE AND HYDROSEED

GRADE CONTROL SCHEDULE				
LINE	FROM STA.	TO STA.	CONTINUOUS SLOPE DIRECTION	
7A	11TH STREET	1+00	3+47	UPWARD
		3+47	14+50	DOWNWARD
7B	FIG STREET	1+00	6+21	UPWARD

- NOTES:**
1. MINIMUM COVER FROM FINISH GRADE TO TOP OF PIPE SHALL BE 2.5 FEET AND 3 FEET UNDER ROADWAYS, UNLESS NOTED OTHERWISE.
 2. MINIMUM SLOPE OF INSTALLED PIPING SHALL BE 0.003 FT/FT.
 3. LOT LINES AND RIGHT-OF-WAYS SHOWN ARE APPROXIMATE ONLY.
 4. IT IS ANTICIPATED THE TELEPHONE, POWER, CABLE T.V., WATER, AND SEWER THAT EXIST WITHIN THE STREET AND UTILITY CORRIDOR AND INDIVIDUALLY PROVIDE SERVICE TO EACH LOT WILL BE ENCOUNTERED DURING CONSTRUCTION. CONTRACTOR SHALL PLAN FOR CROSSING AND/OR EXCAVATING ALONG THESE UTILITIES AT EACH LOT AND/OR WITHIN THE STREET AND UTILITY CORRIDOR WITHOUT ADDITIONAL COMPENSATION.
 5. SERVICES LOCATED DOWNHILL OF MAIN LINE ARE TO DRAIN BACK TO MAIN LINE, UNLESS DESIGNATED "WITH DRAIN".




REVISION	BY	DATE
RECORD DRAWING	B.M.	4/14
DESIGNED BY	H. MORRISON	
DRAWN BY	D. CHRISTMAN	
REVIEWED BY	B. MOORE	

HORIZ. SCALE 1"=50'		VERT. SCALE
JOB NUMBER	1199-336	
DATE	2013	
ACAD FILE	PNP-Phase3C.dwg	
COPYRIGHT 2013 BY ANDERSON-PERRY & ASSOC., INC.		

RECORD DRAWINGS
APRIL 18, 2014

These record drawings have been prepared, in part, on the basis of information compiled and furnished by others. They may contain some discrepancies and omissions, and do not necessarily represent "exact" field conditions. The Owner and the Engineer accept no responsibility for their accuracy.

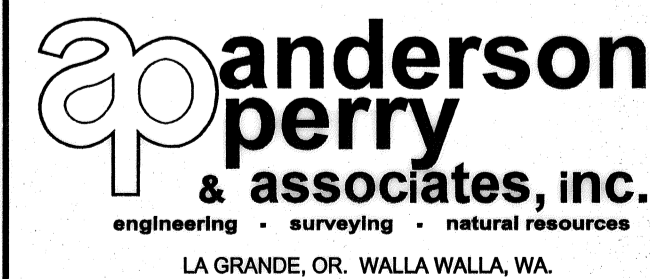

BENTON IRRIGATION DISTRICT
IRRIGATION SYSTEM IMPROVEMENTS
PHASE 3C

PIPING PLANS
11TH STREET AND JANE-IRENE ALLEY

SHEET

7