



- NOTES**
1. SEE SHEETS P1-P3 FOR YARD PIPING DETAILS NOT SHOWN.
 2. DEFLECT PIPING AS REQUIRED TO MAINTAIN ALIGNMENT AS SHOWN. DO NOT EXCEED MANUFACTURER'S ALLOWABLE DEFLECTION PER JOINT.
 3. PROVIDE 3 FT. MINIMUM COVER OVER PIPELINE.

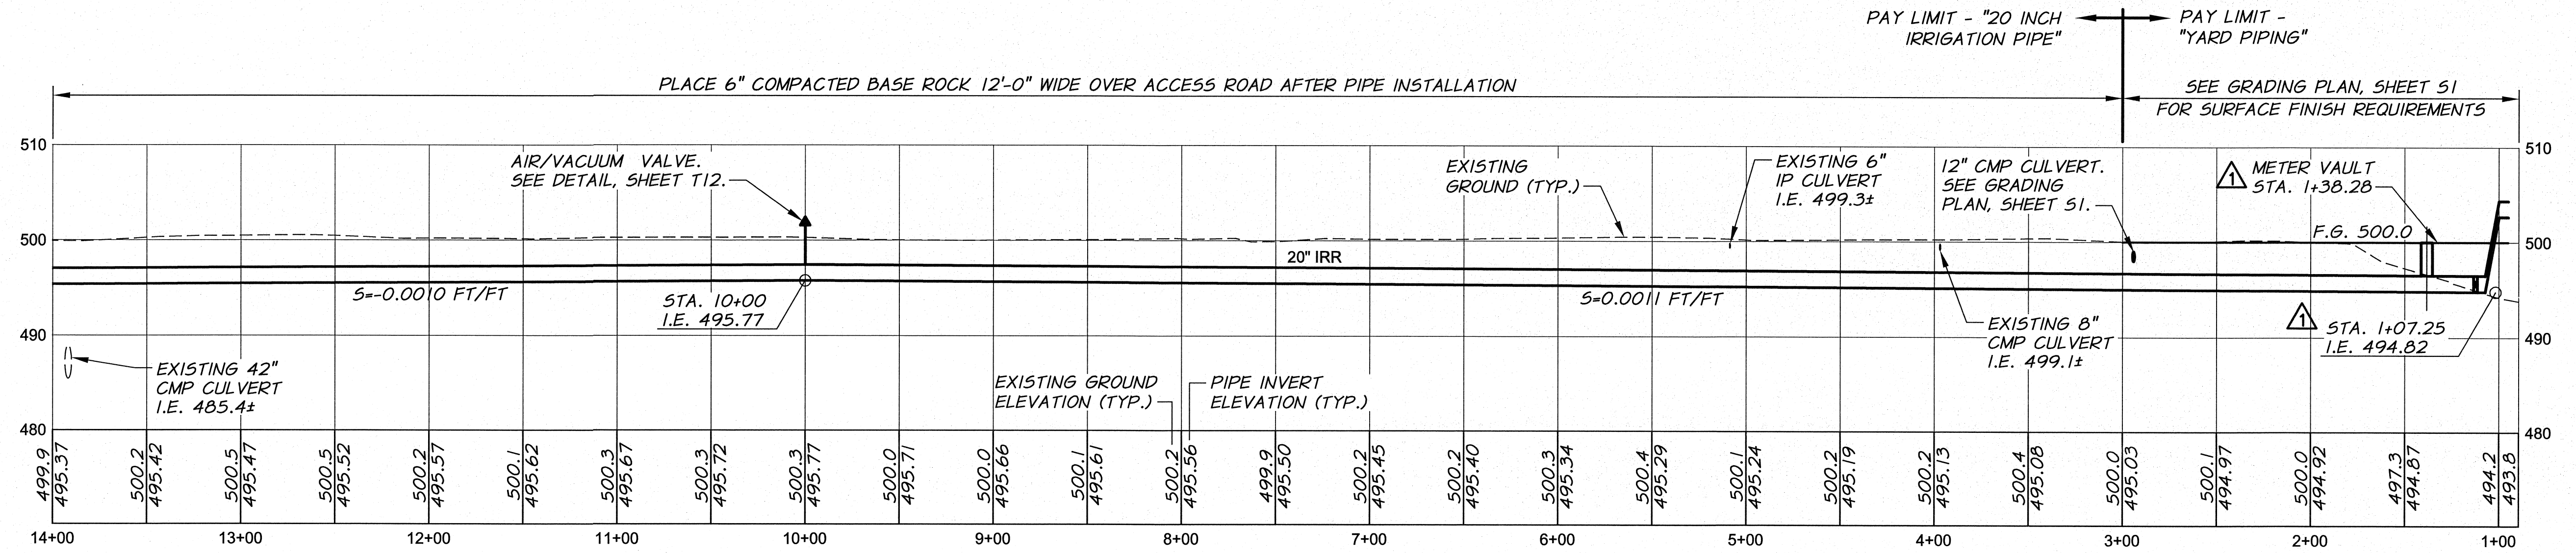

RECORD DRAWINGS		H.P. 11/10		50 0 50 100 150	
REVISION - PIPE ALIGNMENT		B.M. 12/09		10 0 10 20 30	
DESIGNED BY	B. MOORE	XREFS:	TB-PumpSta.dwg	JOB NUMBER	1199-336
DRAWN BY	D. CHRISTMAN	ACAD FILE:	SitePiping.dwg	DATE	2009
REVIEWED BY	H. PERRY	COPYRIGHT 2010 BY ANDERSON-PERRY & ASSOC., INC.			

RECORD DRAWINGS

These record drawings have been prepared, in part, on the basis of information compiled and furnished by others. They may contain some discrepancies and omissions, and do not necessarily represent "exact" field conditions. The Owner and the Engineer accept no responsibility for their accuracy.

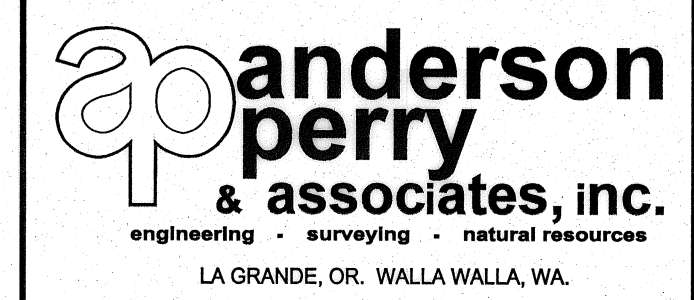

BENTON IRRIGATION DISTRICT
IRRIGATION SYSTEM IMPROVEMENTS
RIVER PUMP STATION

PIPING
NORTH MAIN LINE - PLAN AND PROFILE I

SHEET
P5
19 OF 60